


Control Room

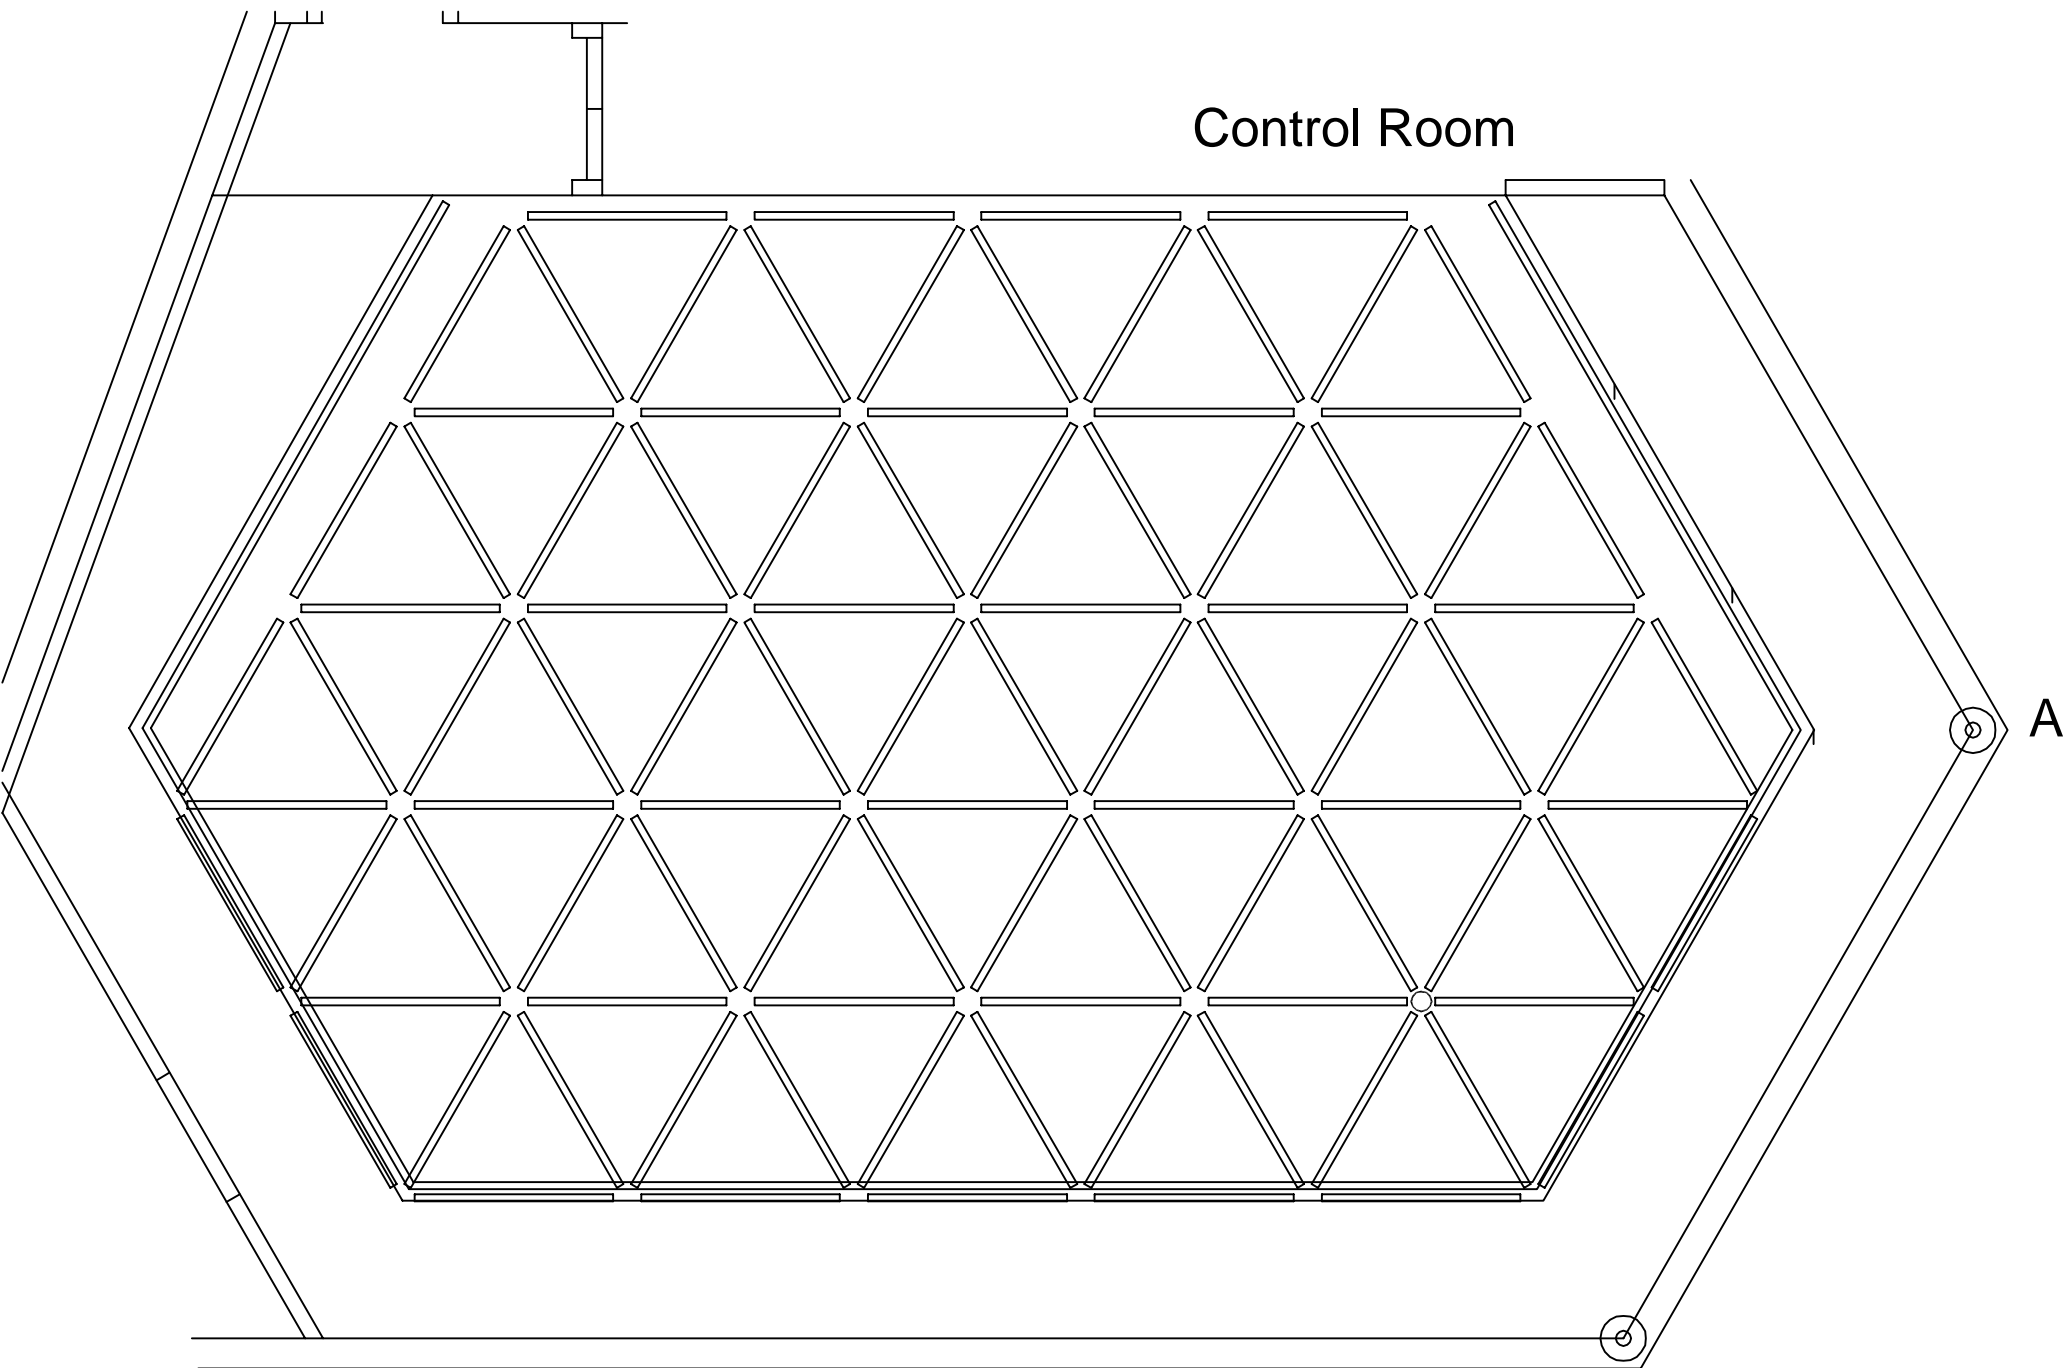

Floor Plan No. 3 (Ceiling Level)

Scale 1:50

